
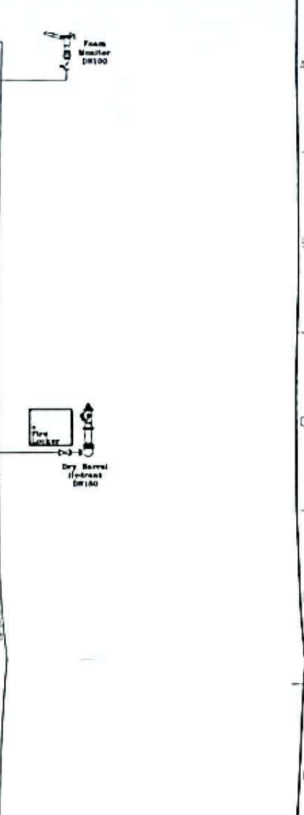


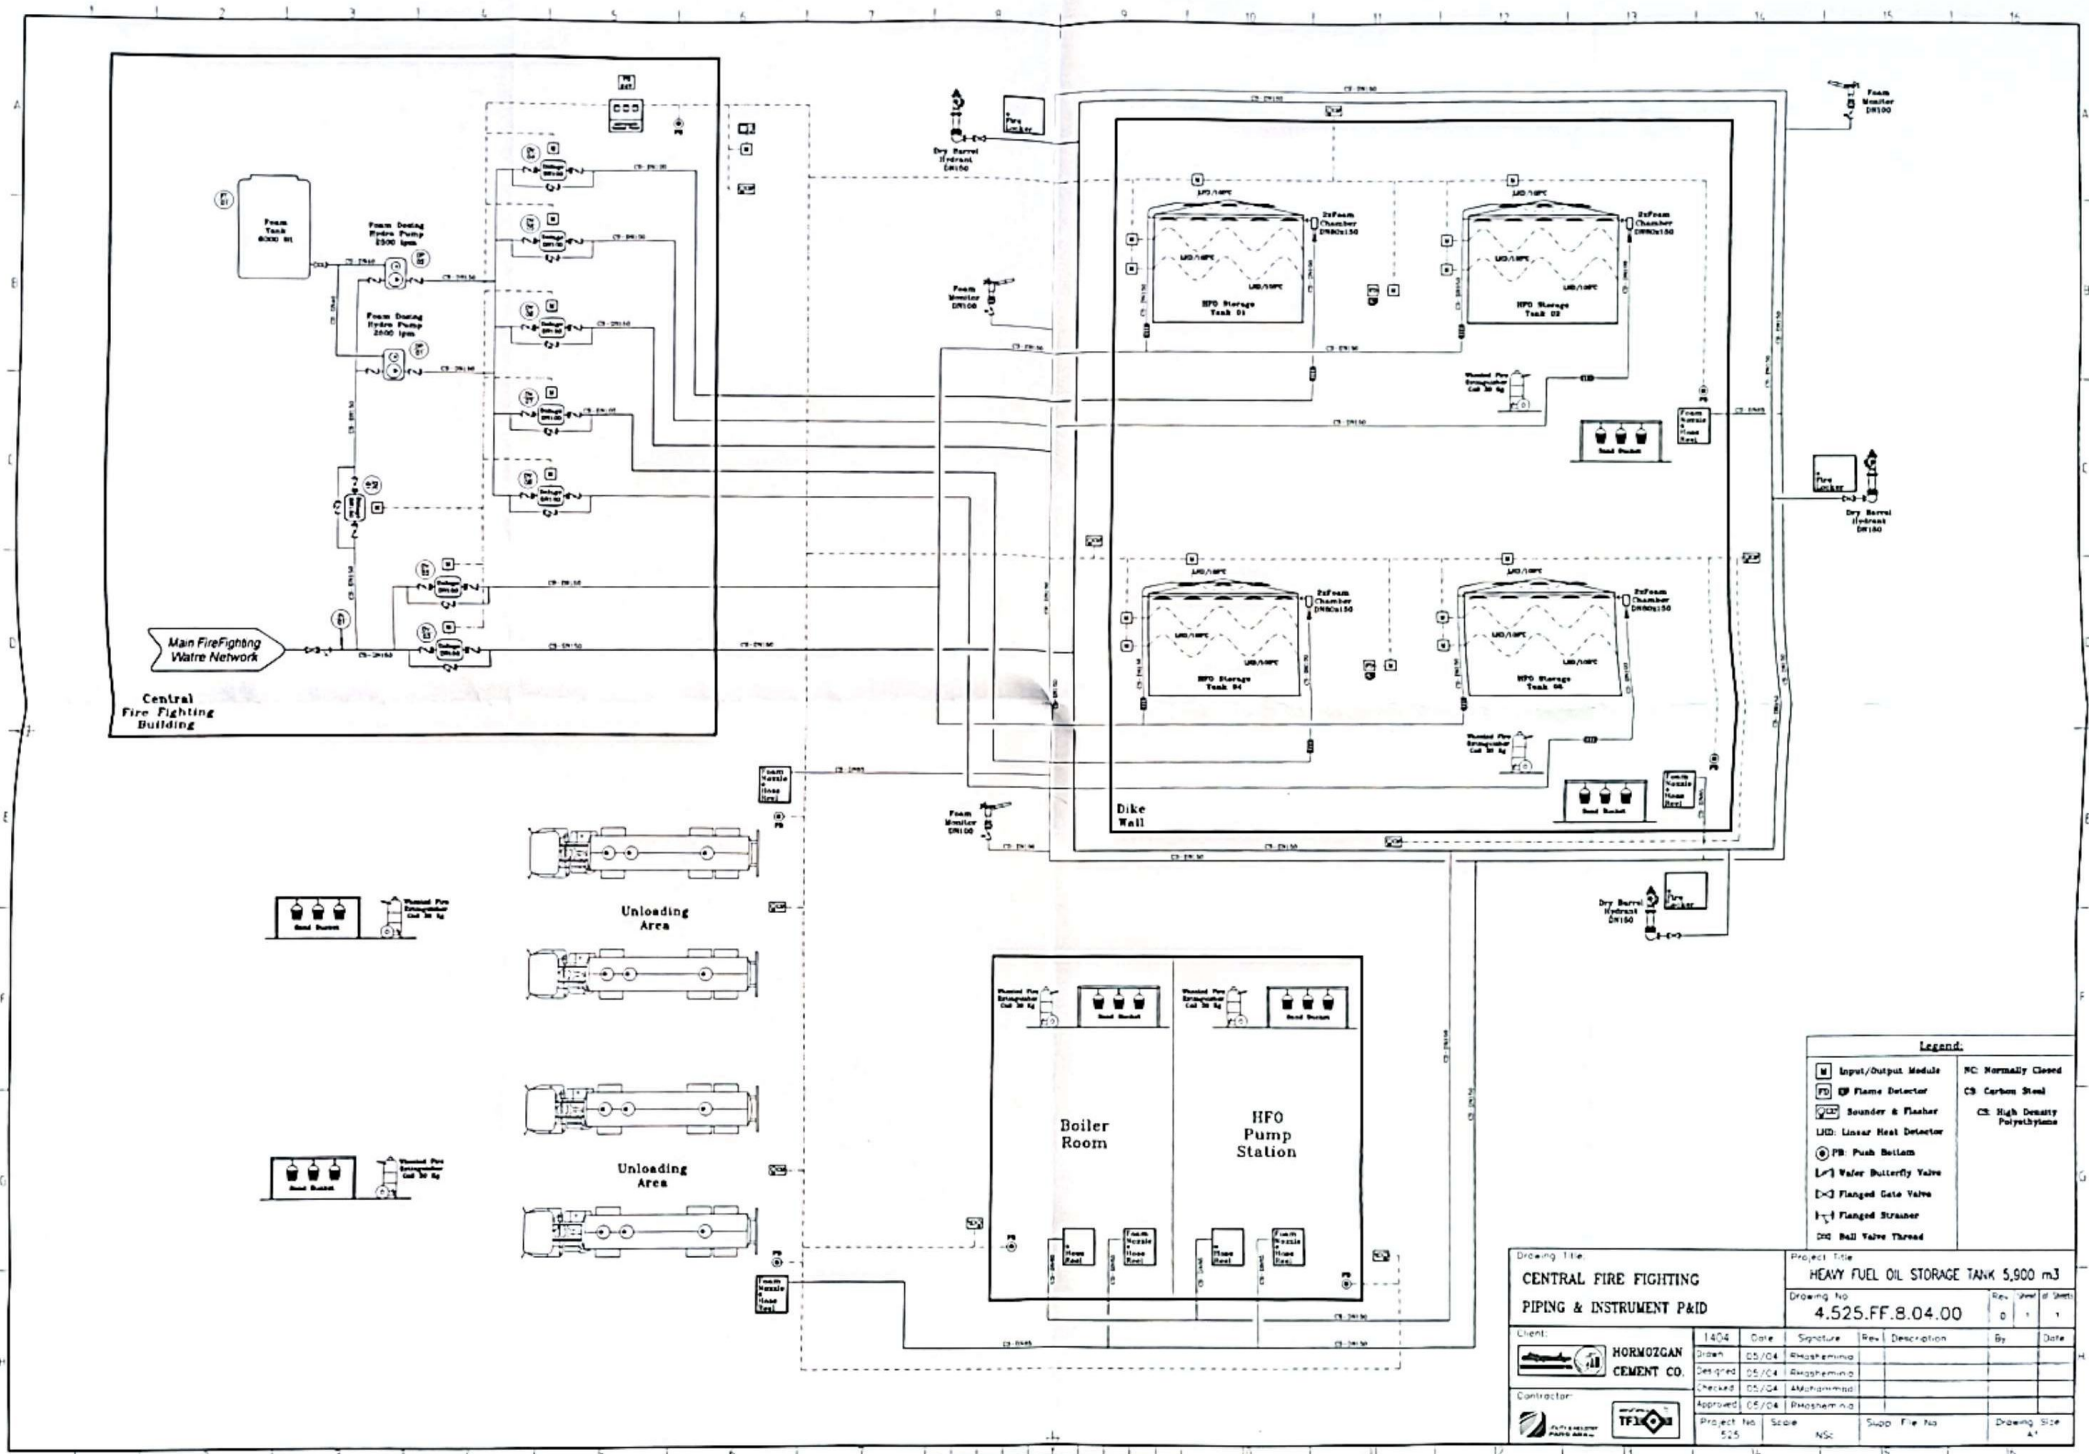

Drawing Title		Project Title	
CENTRAL FIRE FIGHTING		HEAVY FUEL OIL STORAGE TANK 5,900 m ³	
PIPING & INSTRUMENT P&ID		Drawing No. 4.525.FF.8.04.00	
Client	HORMOZGAN CEMENT CO.	1404	Date
Design	05/04	Signature	Rev. Description
Checked	05/04	Signature	By Date
Approved	05/04	Signature	By Date
Contractor	TFI	Project No.	Scale
		525	NSC
		Supp. File No.	Drawing Size
			A1